



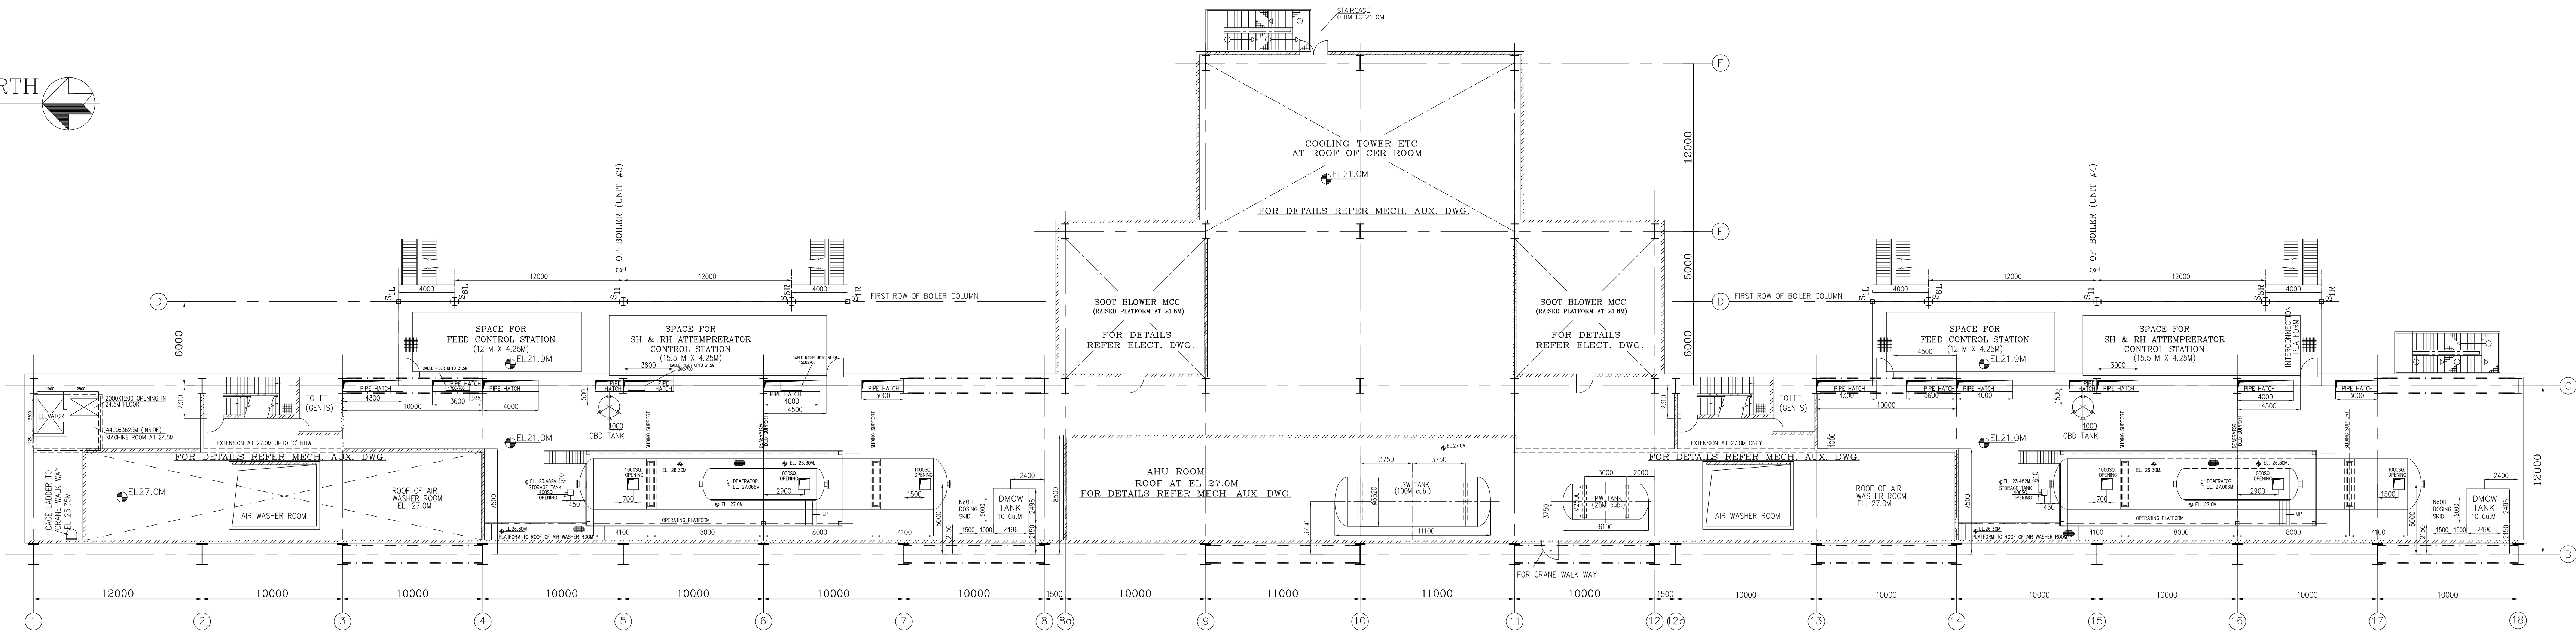

PLAN AT 21.0M

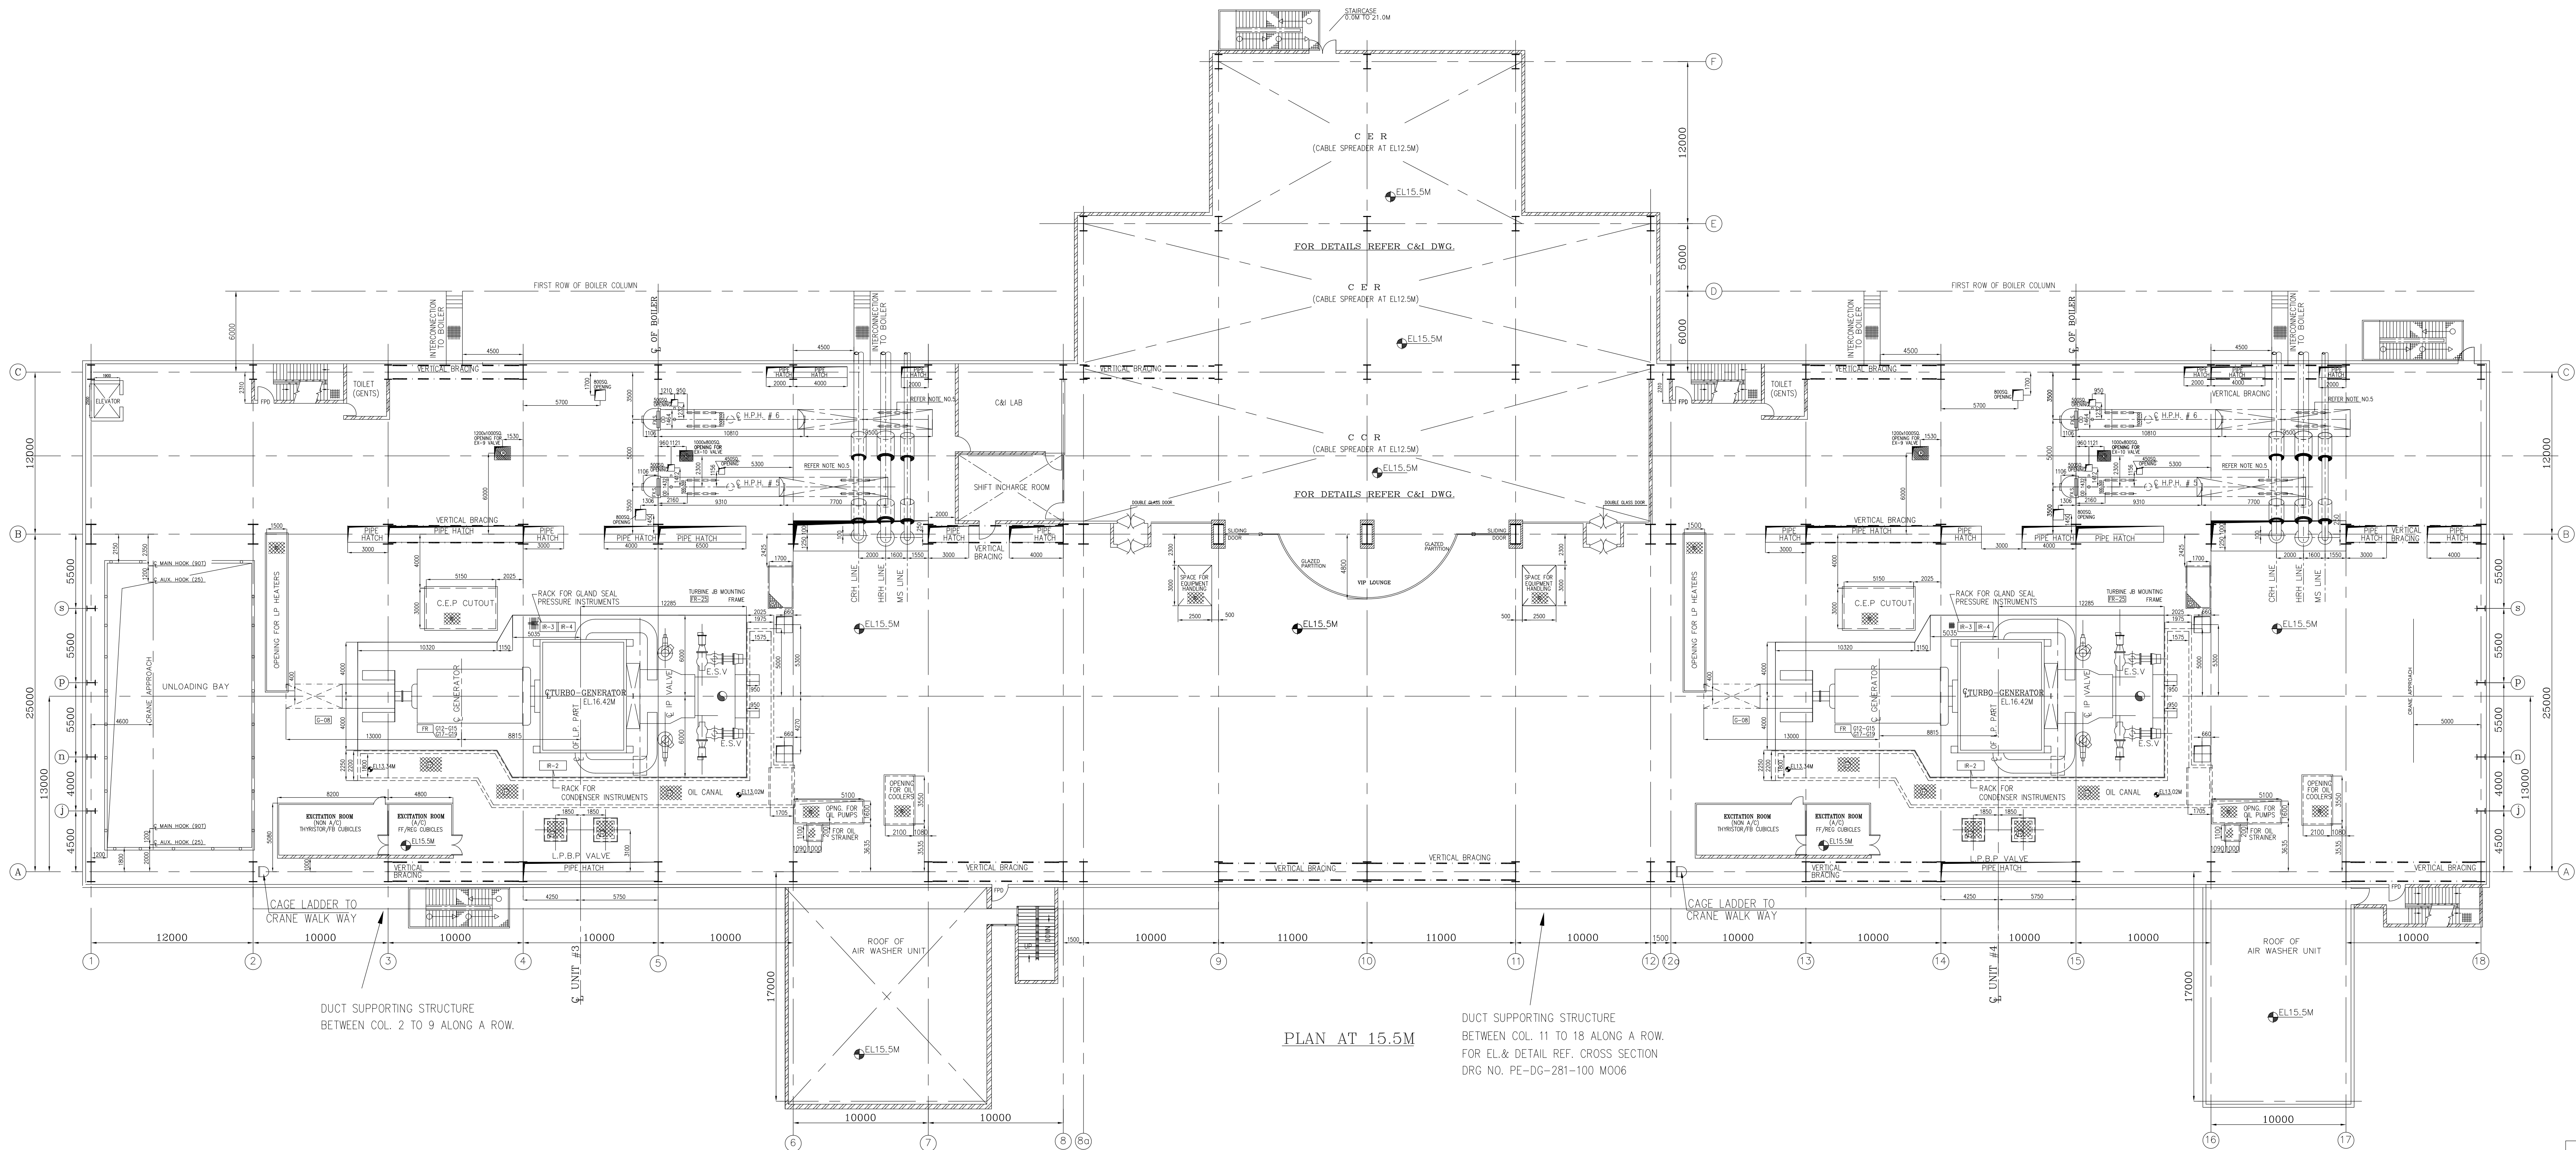

PLAN AT 15.5M

LEGEND:

- CHEQUERED PLATE FLOORING
- REMOVABLE CHEQUERED PLATE
- GRADED FLOORING
- REMOVABLE GRATING
- CONCRETE BLOCK
- CUT OUTS
- HAND RAILING
- PARAPET WALL
- GLASS PARTITION
- BRICK WALL

NOTES:-

- ALL DIMENSIONS ARE IN MM & ELEVATIONS IN METERS UNLESS STATED OTHERWISE.
- TO HALL 0.0M LEVEL CORRESPONDS TO RL +10.5M ABOVE MSL.
- FOR ITS C&I & FLOOR FRAMING REFER CIVIL DRGS. SEPARATELY.
- ALL CIVIL DETAILS SUCH AS DOORS/WALLS/CLOINGS/OPENINGS/TOILETS/STAIRCASES ETC. ARE INDICATIVE ONLY & FOR EXACT DETAILS REFER CIVIL/ARCHITECTURE DRAWINGS.
- CIVIL TO PROVIDE 2ND & EPS (TOS) 150MM WIDE X 1350MM LONG FOR HPH-5, 150MM WIDE X 1800MM LONG FOR HPH-6 FOR MOVEMENT OF LP HEATERS AS PER LOCATION SHOWN IN THE DWG.

REFERENCE DRGS.:-

- | | |
|-----------------------------------|--------------------------|
| 1. CONDENSER | 0-160-10-70055C131 (HWR) |
| 2. GENERATOR OUTLINE | 0-139-00-01275 (HWR) |
| 3. FOUNDATION PLAN | 0-13000-A5163 (HWR) |
| 4. OIL CANAL DETAILS | 0-13100-A5001 (HWR) |
| 5. OIL ROOM ARRANGEMENT | 0-13100-A5004 (HWR) |
| 6. GA OF HP HEATER # 5 | 1-17500-40119 (BPL) |
| 7. GA OF HP HEATER # 6 | 1-17500-40120 (BPL) |
| 8. GA OF SPARY CLIM TRAY DEAEATOR | 1-163-10-11260 (HYD) |
| 9. GA OF SERVICE WATER TANK | 1-17052-40229 (BPL) |
| 10. GA OF POTABLE TANK | 1-17052-40230 (BPL) |
| 11. GA OF DCMW TANK | 1-17052-40231 (BPL) |

TCE DRG. No. - TCE.5064A-EPC-BH(PEM)-M005

CUSTOMER	GUJARAT STATE ELECTRICITY CORPORATION LTD.								
CUSTOMER'S CONSULTANT	TCE CONSULTING ENGINEERS LIMITED								
JOB No.	281								
STATUS	CONTRACT								
DISTRIBUTION									
TO									
REV	DATE	ALTD	CHD	APPO	REV	DATE	ALTD	CHD	APPO
02	14.09.09				01	13.03.08			
1. SERVICE WATER/POTABLE WATER & DCMW TANK DIMENSIONS & LOCATION REVISED.									
2. FLOOR OPENINGS UPDATED.									
3. HP HEATERS DETAIL UPDATED.									
4. AIR WASHER ROOM UNIT#4 LOCATED AT 9.0M									
5. HIGH DCMW S&S SHOWN IN PLAN AT 21.0M DWG. GENERALLY REVISED & UPDATED.									
6. SERVICE WATER/POTABLE WATER & DCMW TANK DIMENSIONS & LOCATION REVISED.									
7. FLOOR OPENINGS UPDATED.									
8. HP HEATERS DETAIL UPDATED.									
9. AIR WASHER ROOM UNIT#4 LOCATED AT 9.0M									
10. HIGH DCMW S&S SHOWN IN PLAN AT 21.0M DWG. GENERALLY REVISED & UPDATED.									
11. SERVICE WATER/POTABLE WATER & DCMW TANK DIMENSIONS & LOCATION REVISED.									
12. FLOOR OPENINGS UPDATED.									
13. HP HEATERS DETAIL UPDATED.									
14. AIR WASHER ROOM UNIT#4 LOCATED AT 9.0M									
15. HIGH DCMW S&S SHOWN IN PLAN AT 21.0M DWG. GENERALLY REVISED & UPDATED.									
T.G.HALL EQUIPMENT LAYOUT PLAN AT 15.5M & 21.0M FLOOR									
MPL C WSE I MAX E DEPT. SCALE 1:200 DRAWING No. PE-DG-281-100-M005									
SHEET 1 OF 1 REV 02									